


National Accelerated National Bridge Conference

December 7-8, 2017

Hyatt Regency Miami Downtown_Regency Ballroom & Promenade Lower Miami, FL

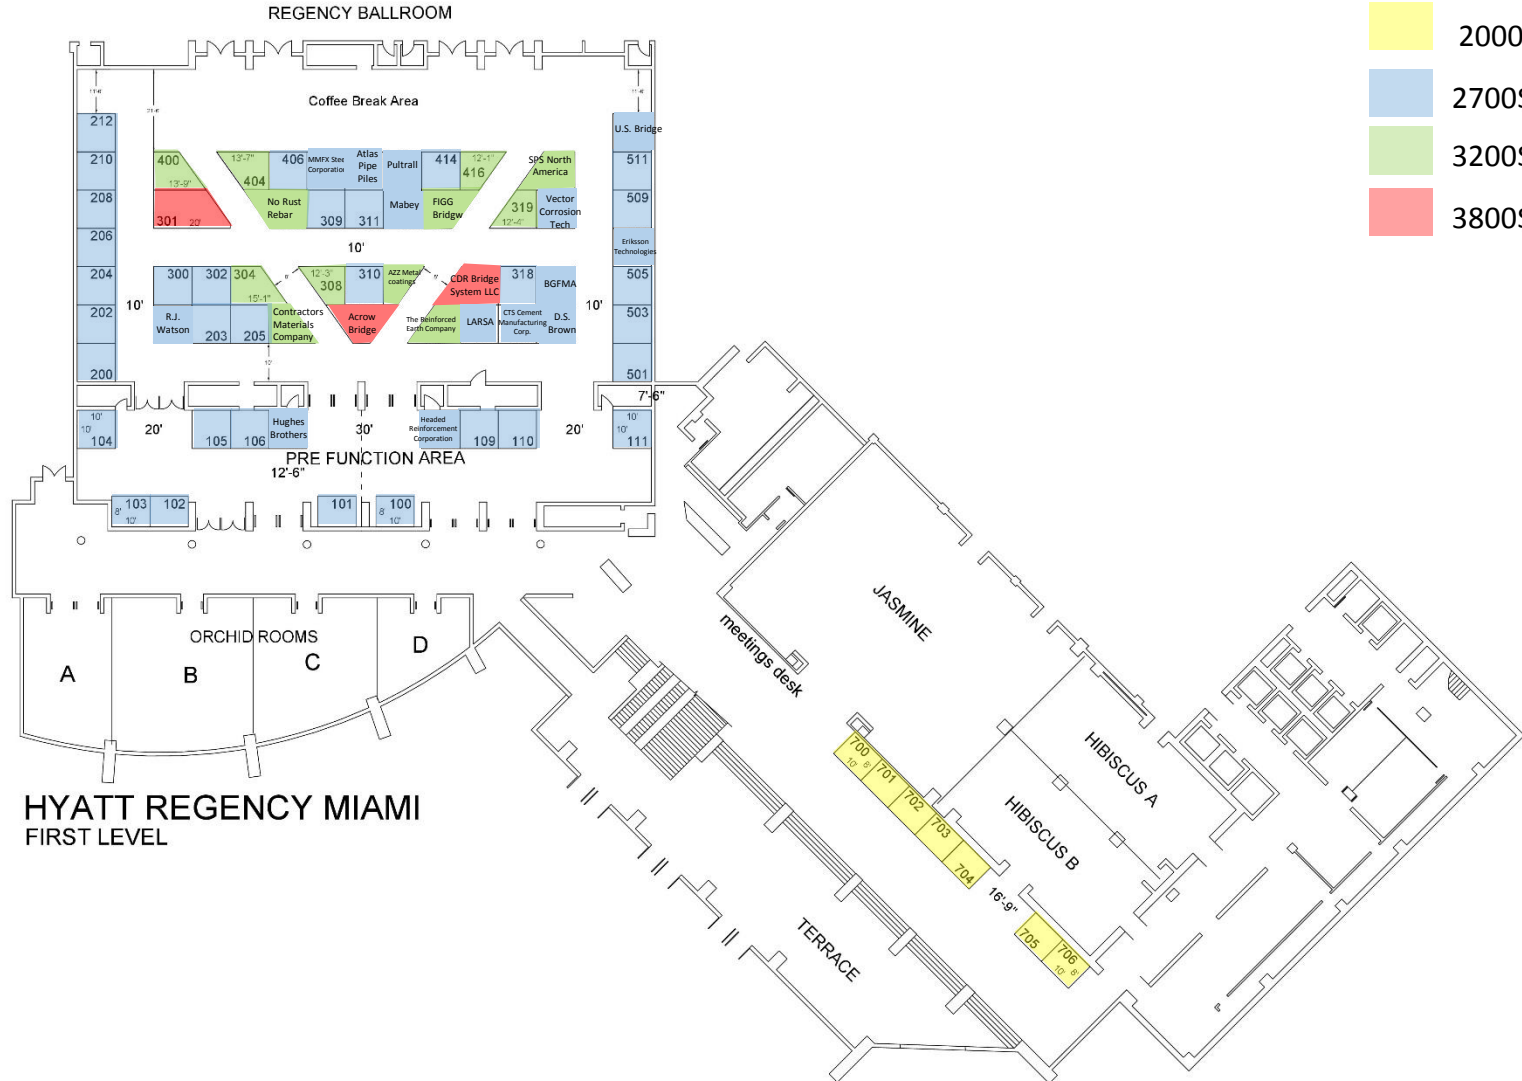

Color	Price
	2000\$
	2700\$
	3200\$
	3800\$



Show Information	
Show Name	National Accelerated National Bridge Conf
Show Dates	12/07-08/17
Move-In	12/06/17
Job #	F127501217
AE	Amy Barkley

Inventory as of 09/01/2016 1:50pm			
Dimension	Size	Qty	SqFt
10'x10'	100	42	4,200
8'x10'	80	11	880
Custom	72	1	72
Custom	85	1	85
Custom	86	1	86
Custom	87	1	87
Custom	88	1	88
Custom	100	1	100
Custom	102	2	203
Custom	114	1	114
Custom	115	1	115
Custom	116	1	116
Custom	117	1	117
Custom	129	1	129
Custom	130	1	130
Custom	172	1	172
Totals:			68 6,694

Icon	Floor Plan Legend
?	?
?	?
?	?
?	?
?	?

Venue Info	
Building Name	Hyatt Regency Miami Downtown
Hall	Regency Ballroom & Promenade Lower
Floor	First Floor
Address	400 SE 2nd Ave, Miami, FL 33131

Drawing Information	
File Path	U:\2016\Projects\12-18-16\12-18-16\12-18-16.dwg
File Name	12-18-16.dwg
Drawn By	JIP
Last Saved	8/29/2016 9:38 PM
Saved By	jsper
Tab	Floorplan
Paper Size	ARCHIT (11.0000 x 21.0000 inches)
Scale	1" = 1'-0"

Fire Marshal Info	
Exhibit Type	Trade Show
Size	See Inventory
Materials	Pipe & Drapo
Name	Michael Ascolese
Number	404-720-8616
Occupancy	Occupancy Load ?
Occupancy	Total Sq Ft of Show ?

1531 Carroll Drive NW
Atlanta, GA 30318
(v) 404-720-8600
(f) 404-720-8750

Shepard Exposition Services has made every effort to ensure the accuracy of all information contained on this floor plan. However, no warranties, either expressed or implied, are made with respect to this floor plan. If the location of building columns, utilities or other architectural components of the facility is a sole responsibility of the exhibitor/show management to physically inspect the facility to verify all dimensions and locations.
SUBJECT TO FIRE MARSHAL APPROVAL